


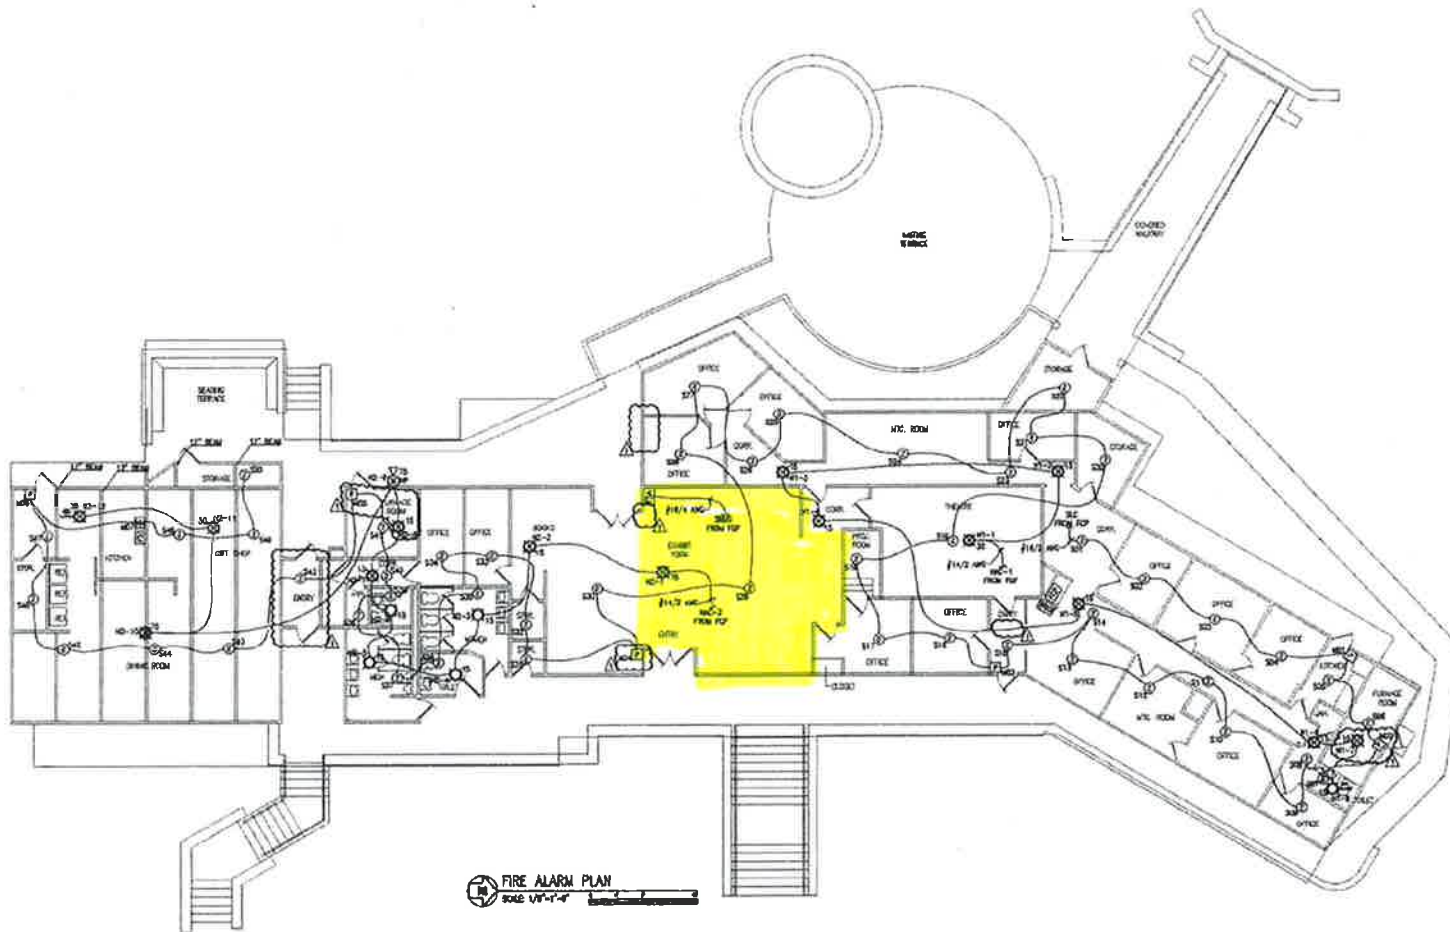

FIRE ALARM PLAN
SCALE 1/8"=1'-0"



LEHMAN CAVE VISITOR CENTER
GREAT BASIN NATIONAL PARK
BAKER, NEVADA 89311
FIRE ALARM PLAN

DESIGN	CHL	LEHMAN JOB #1000
CHECKED	WAYNE D. DAVIS	11/14/05
DATE	11/14/05	
REVISION	1	
SCALE	1/8"=1'-0"	

FA-1

REVISION	DESCRIPTION	DATE
0	DESIGNED FOR LEHMAN & ASSOCIATES	11/14/05
1	REVISED FOR LEHMAN & ASSOCIATES	11/14/05
2	REVISED FOR LEHMAN & ASSOCIATES	11/14/05
3	REVISED FOR LEHMAN & ASSOCIATES	11/14/05
4	REVISED FOR LEHMAN & ASSOCIATES	11/14/05
5	REVISED FOR LEHMAN & ASSOCIATES	11/14/05
6	REVISED FOR LEHMAN & ASSOCIATES	11/14/05
7	REVISED FOR LEHMAN & ASSOCIATES	11/14/05
8	REVISED FOR LEHMAN & ASSOCIATES	11/14/05
9	REVISED FOR LEHMAN & ASSOCIATES	11/14/05
10	REVISED FOR LEHMAN & ASSOCIATES	11/14/05

StateFire
DC Specifications LLC
CORPORATE OFFICE
1111 N. 1st St., Suite 100
Baker, NV 89311
702-734-2200
www.statefire.com