 



TOILET ELEVATIONS


SCALE: 1/4" = 1'-0"

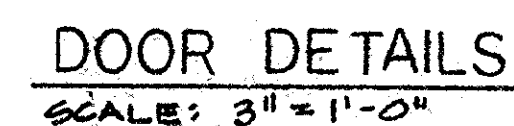


SCALE: 3" = 1'-0"

REVISED 8-11-81 P.H.D.


DRAWING NO.	
326	
80006	
PCIP PKG.	SHEET
—	1
—	OF 3

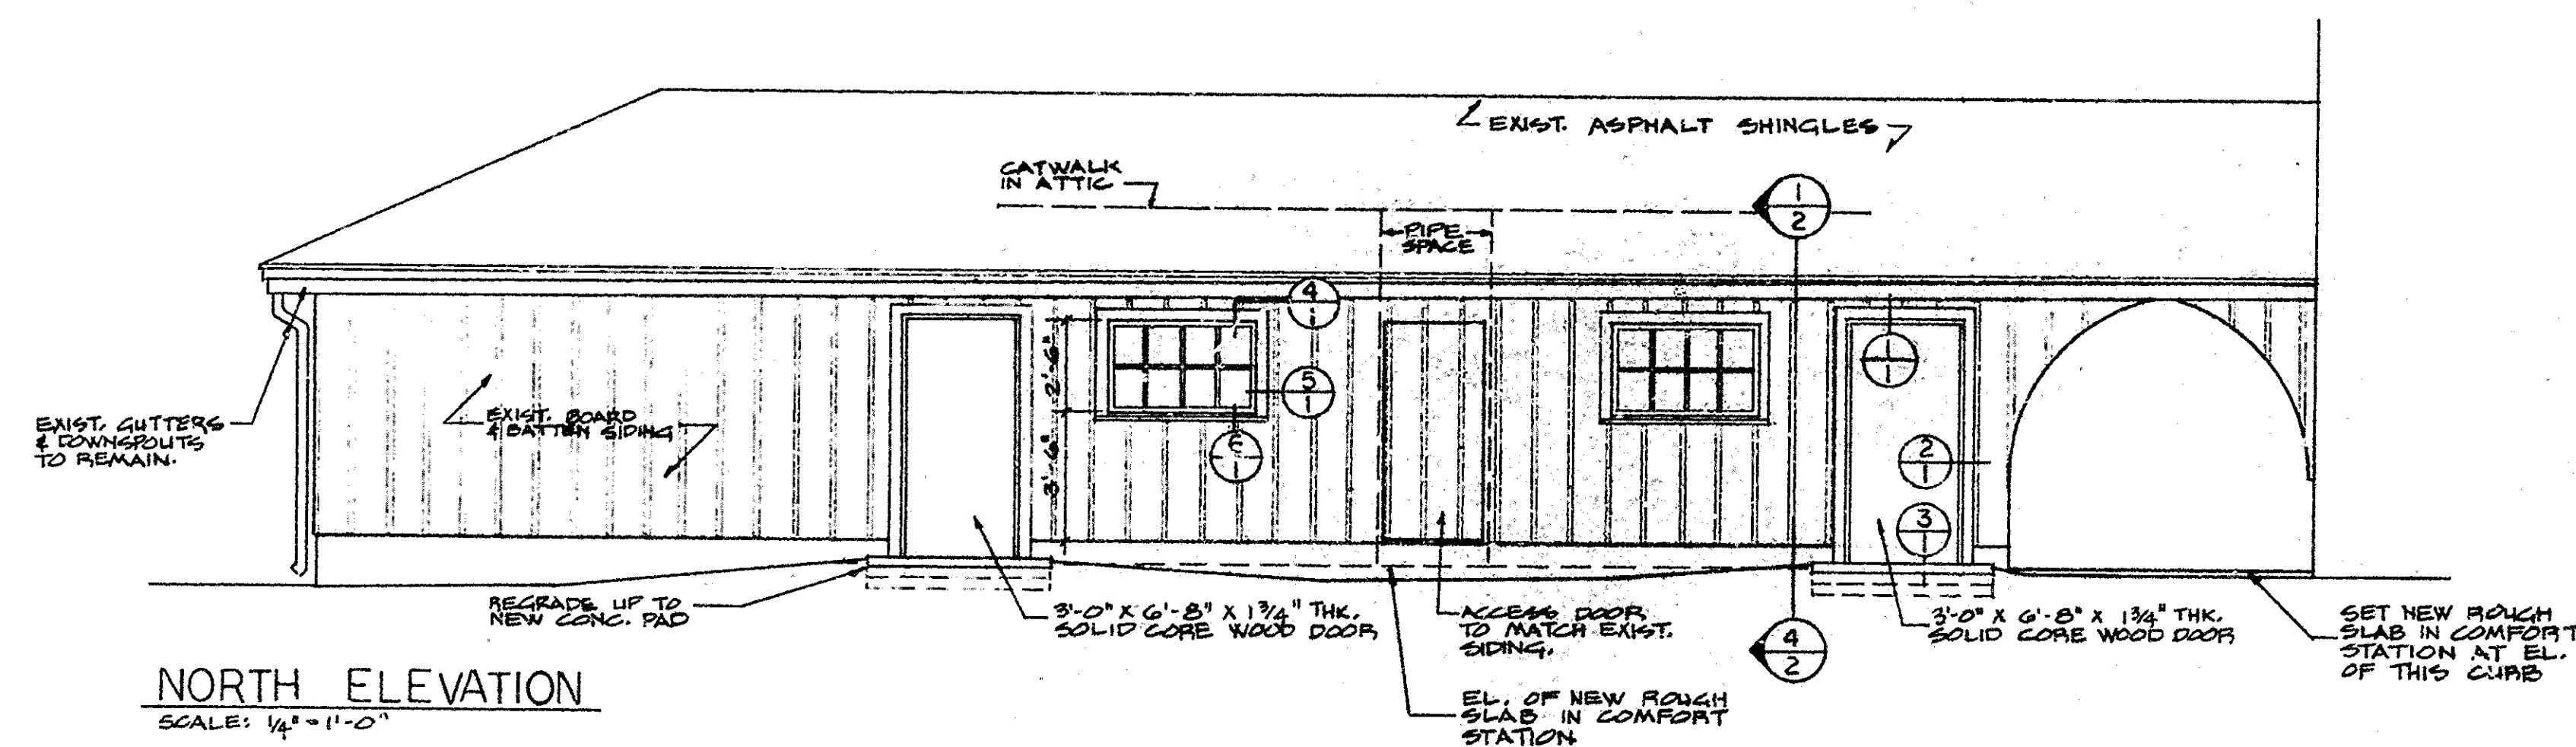


NORTH ELEVATION
SCALE: 1/4" = 1'-0"

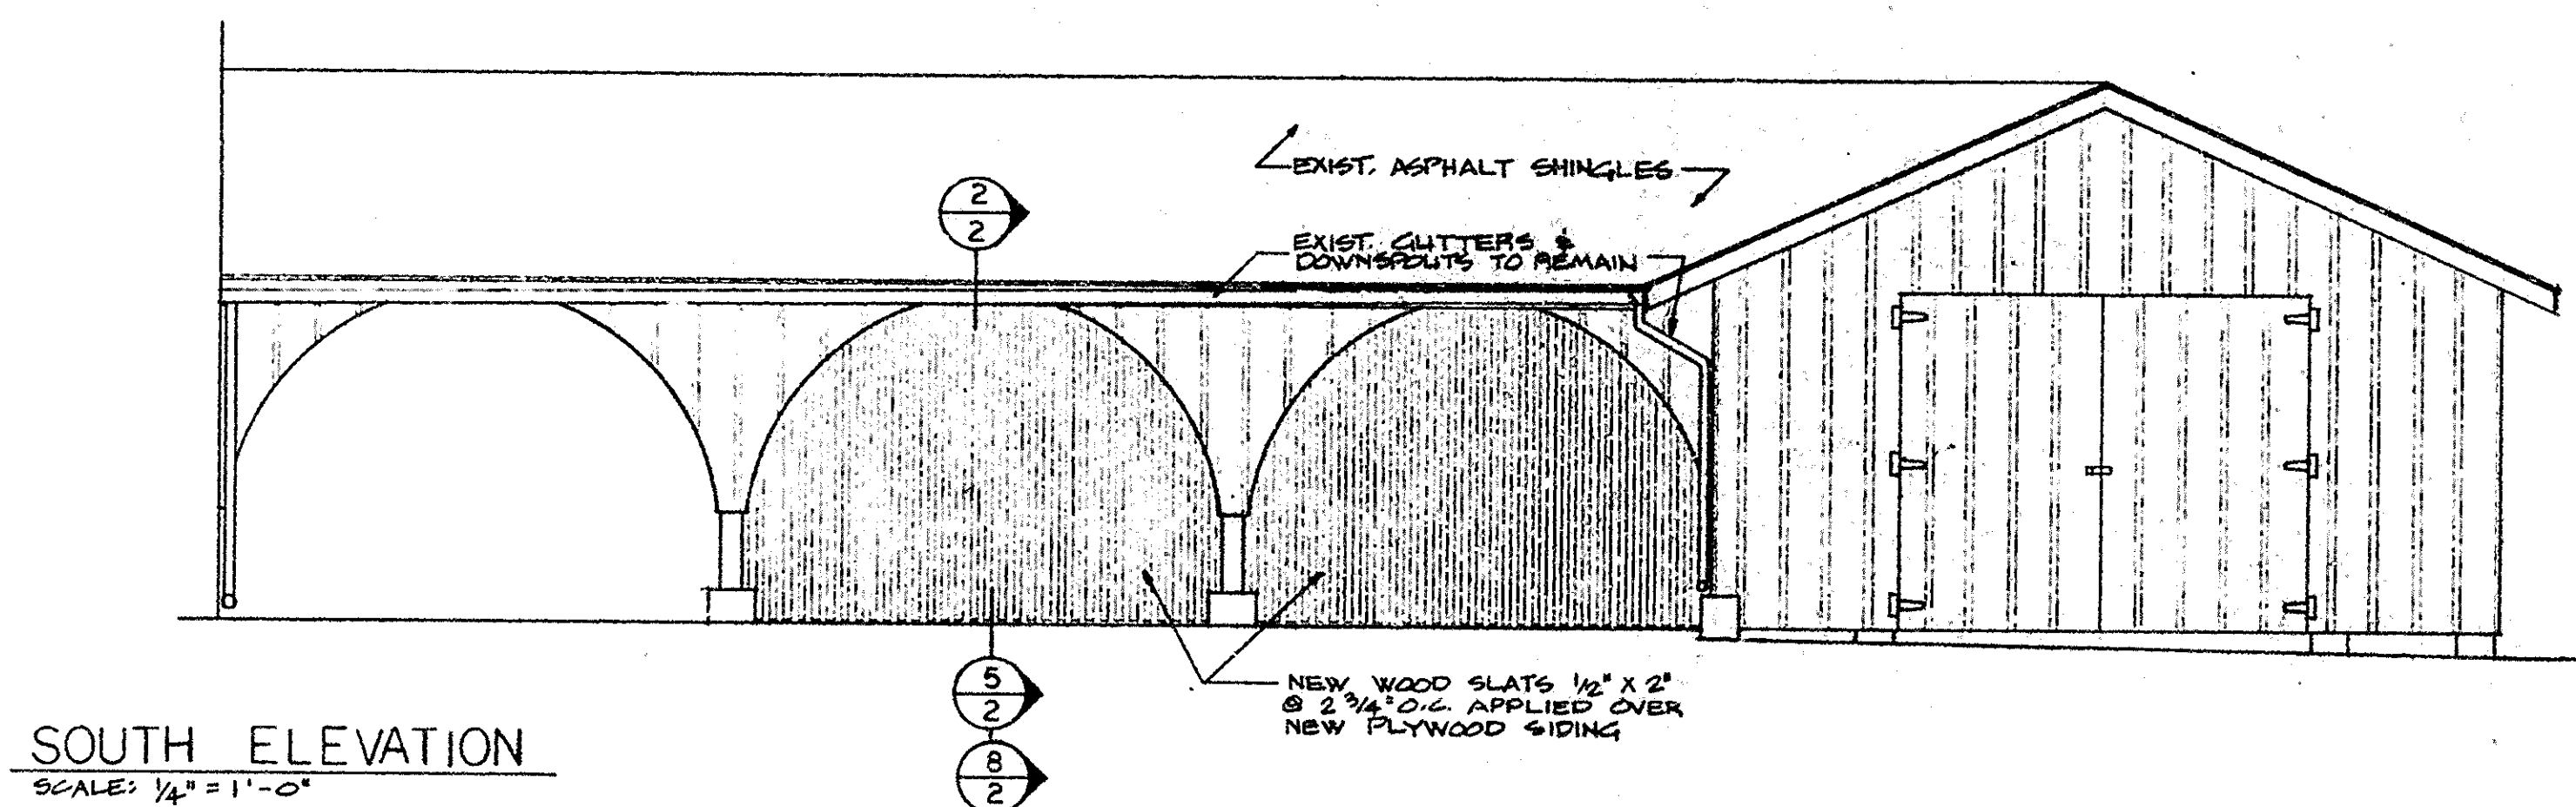


SOUTH ELEVATION
SCALE: 1/4" = 1'-0"

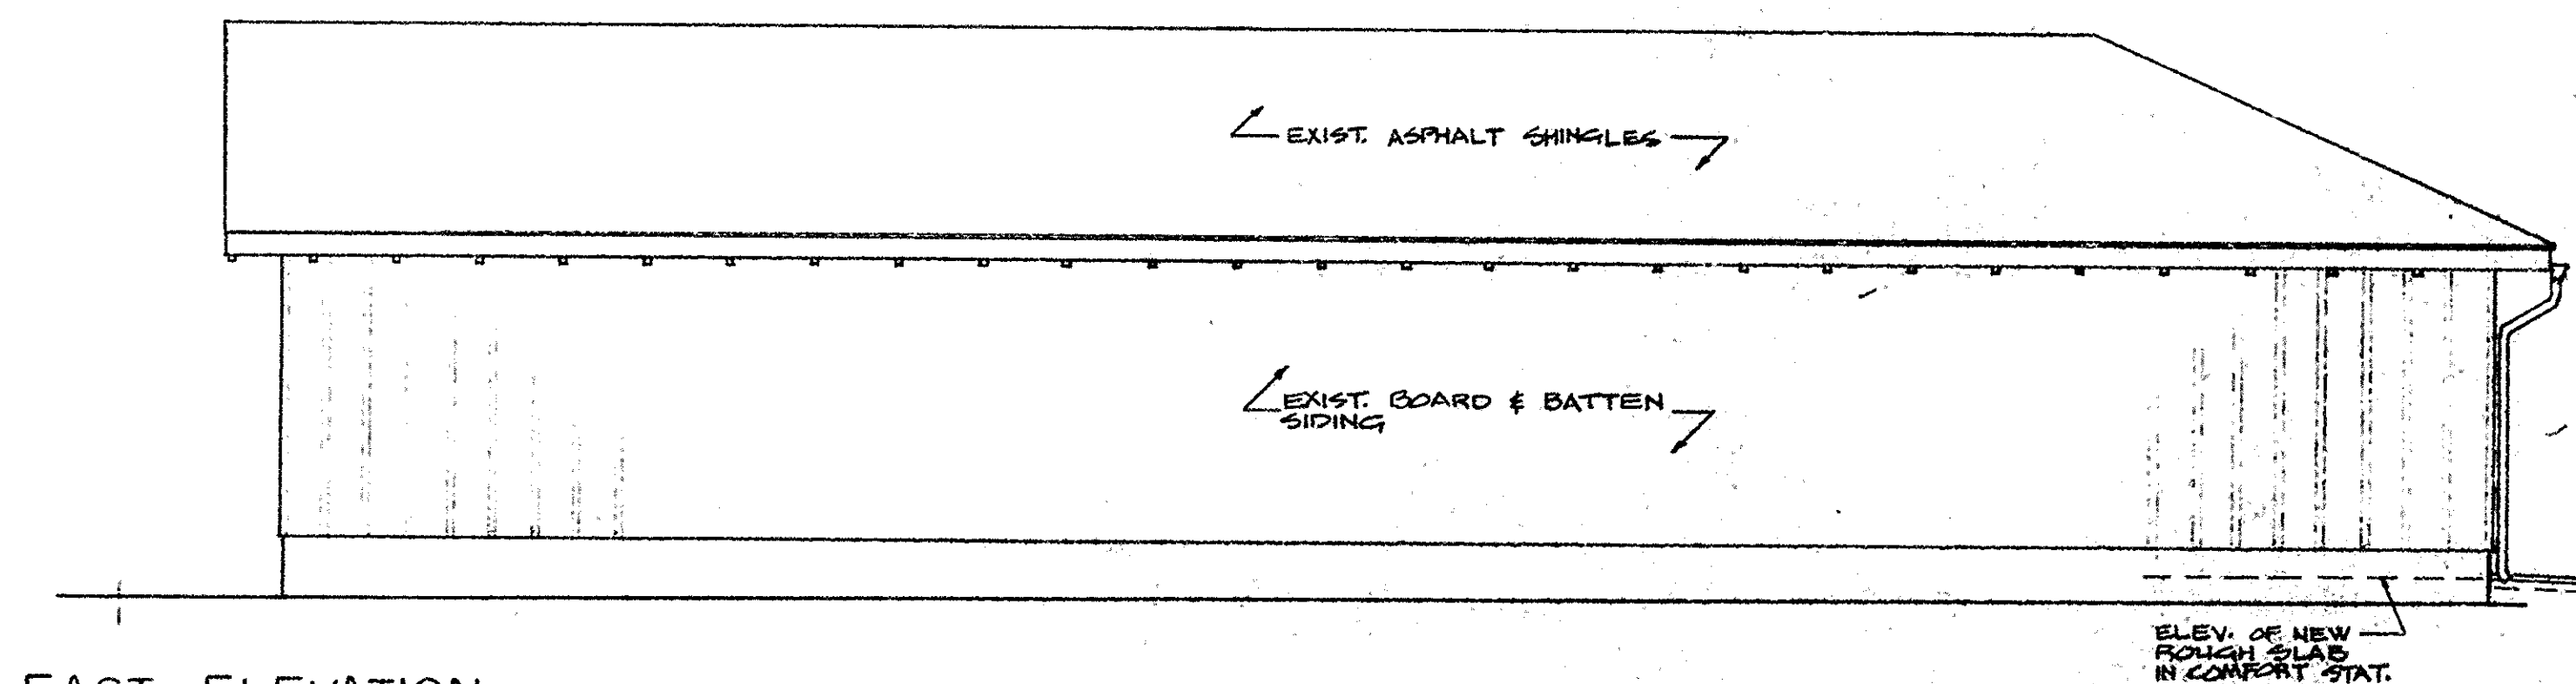


EAST ELEVATION
SCALE: 1/4" = 1'-0"

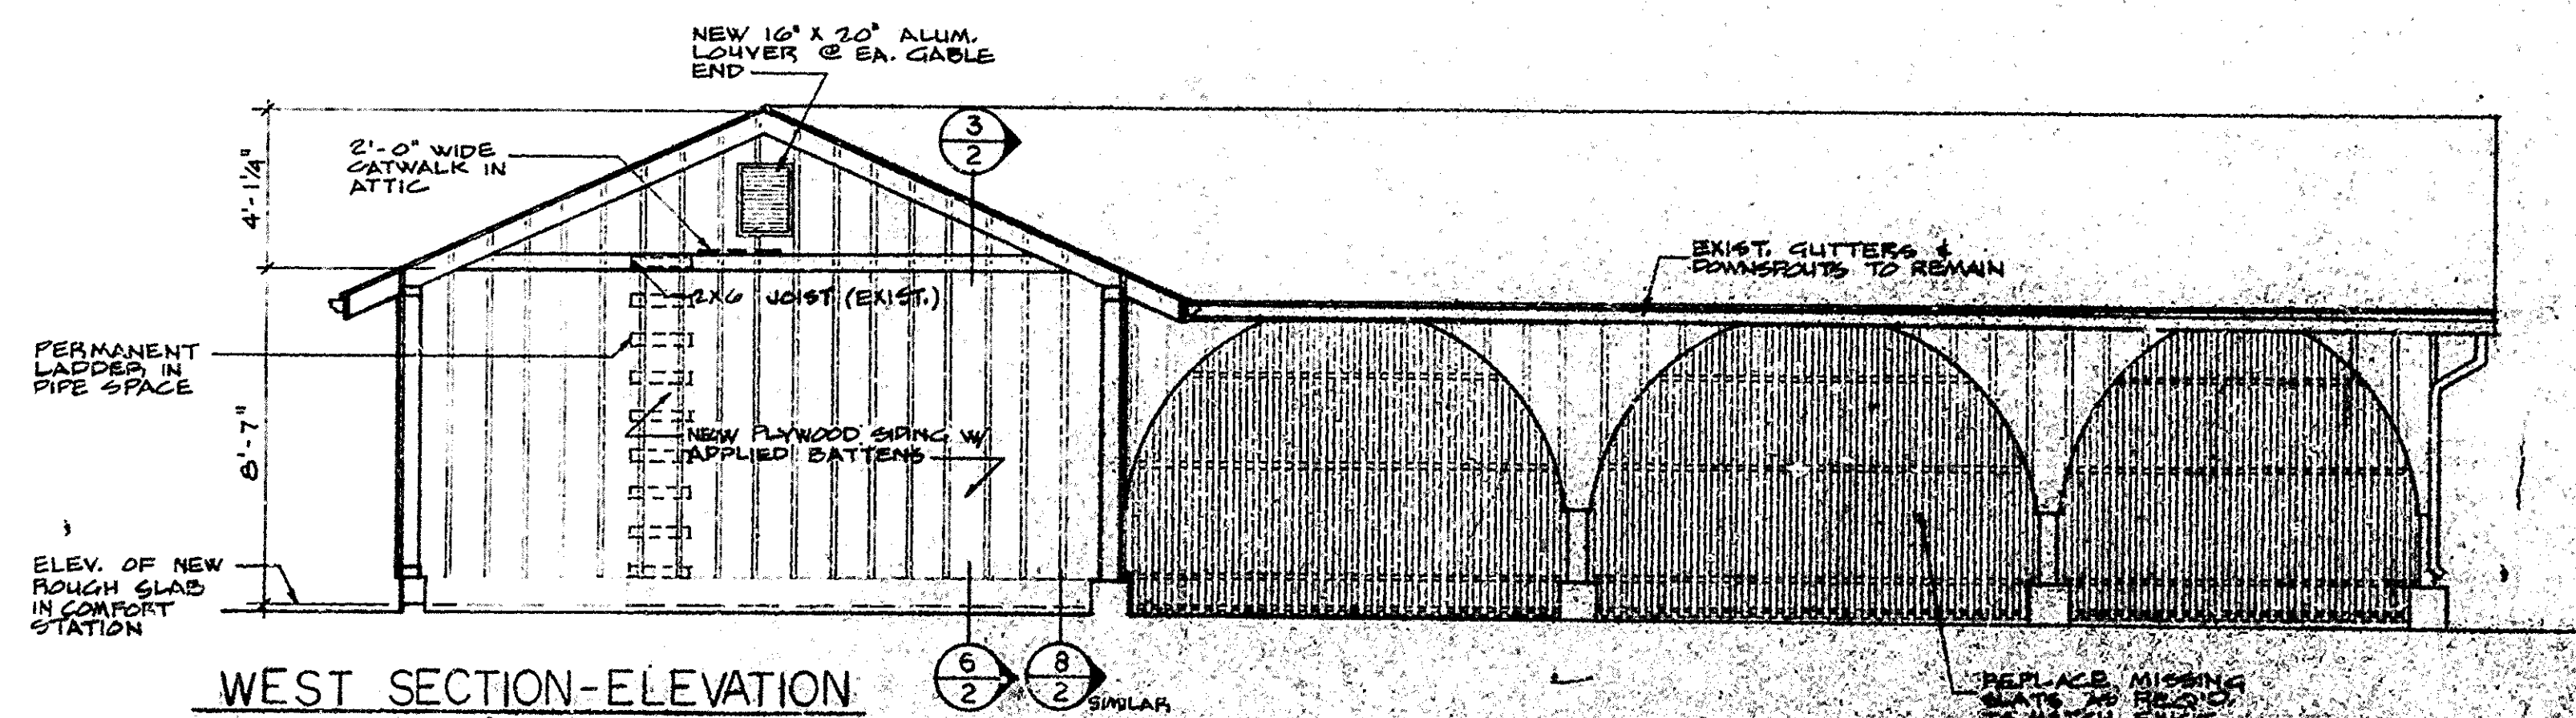


WEST SECTION-ELEVATION
SCALE: 1/4" = 1'-0"

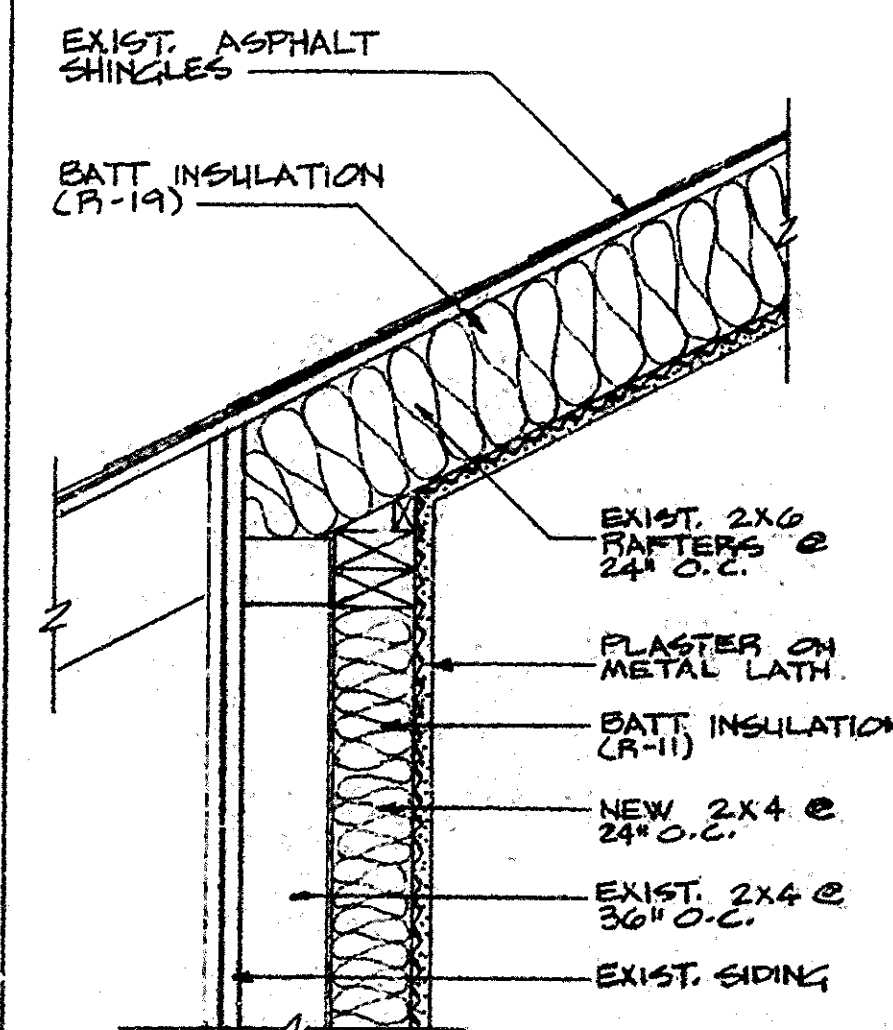


1 TOP OF NORTH WALL
SCALE: 1/2" = 1'-0"

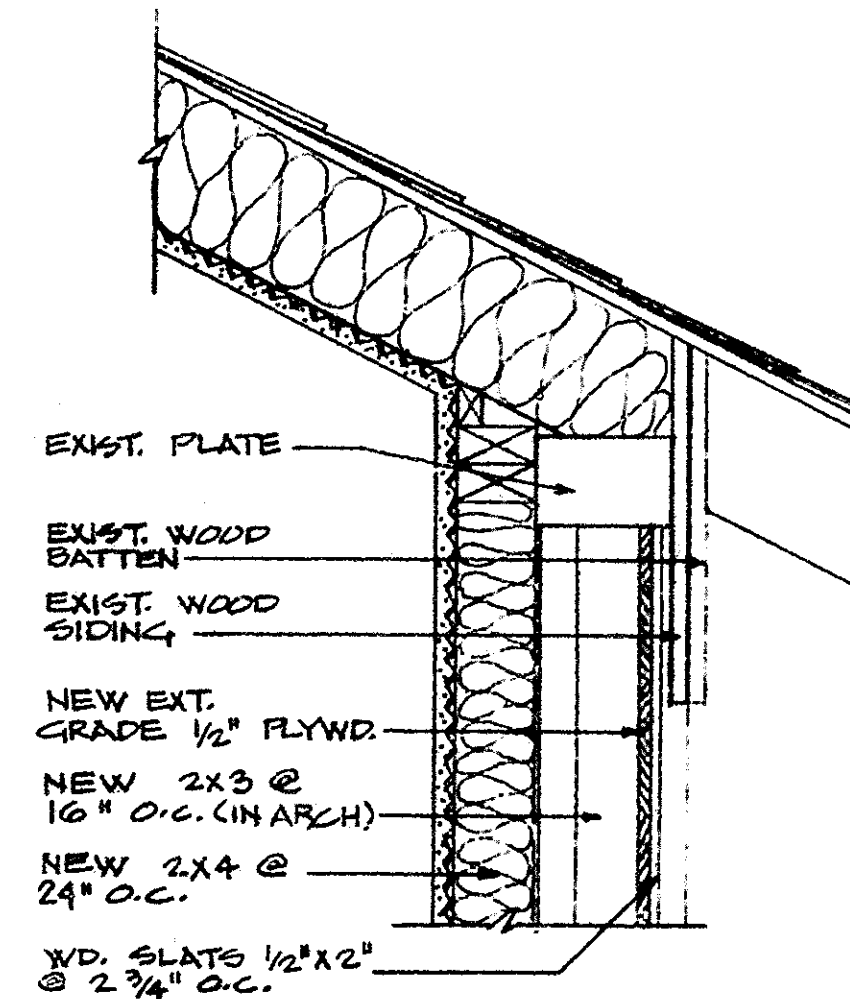


2 TOP OF SOUTH WALL
SCALE: 1/2" = 1'-0"

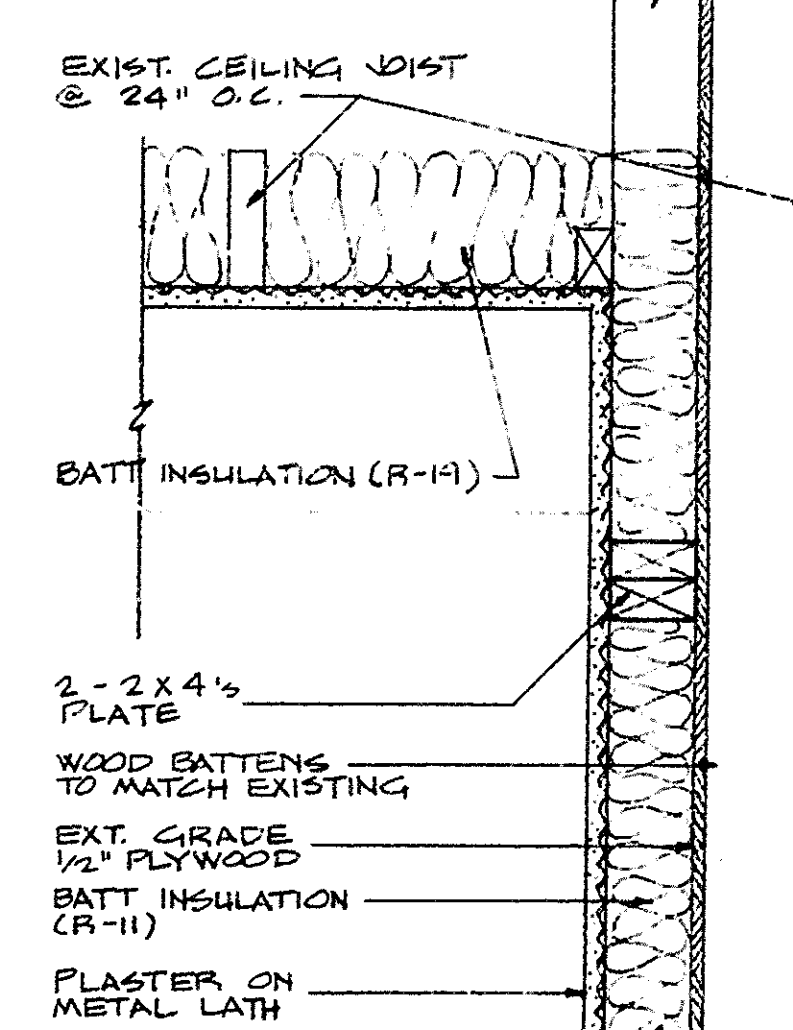


3 EAST OR WEST WALL
SCALE: 1/2" = 1'-0"

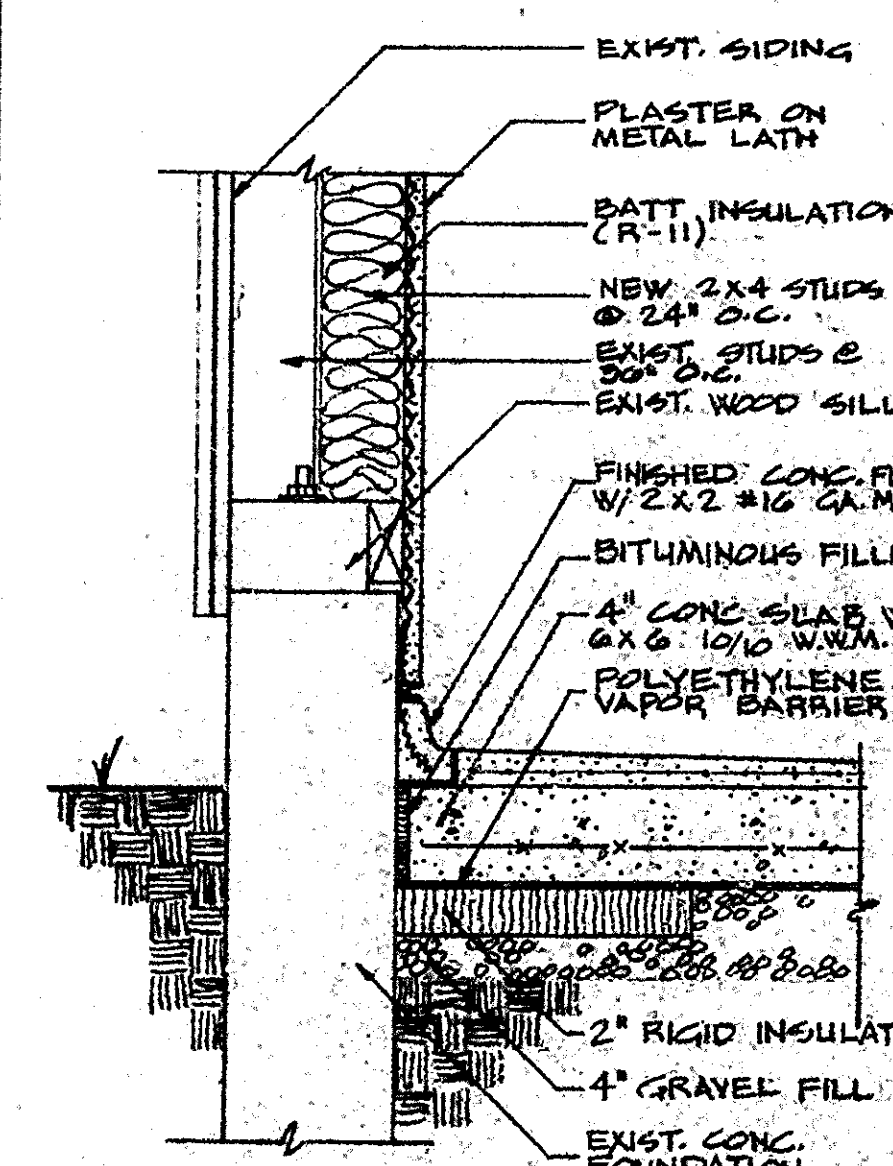


4 FOUNDATION
SCALE: 1/2" = 1'-0"

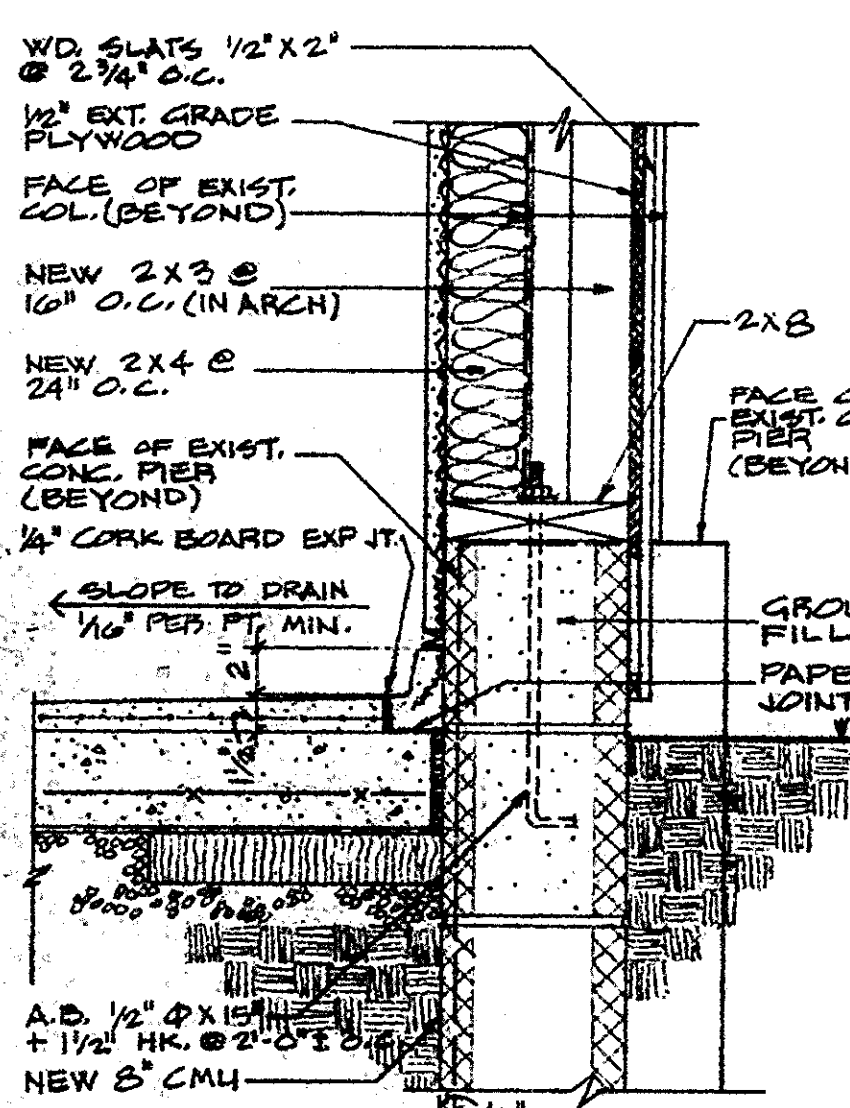


5 FOUNDATION
SCALE: 1/2" = 1'-0"

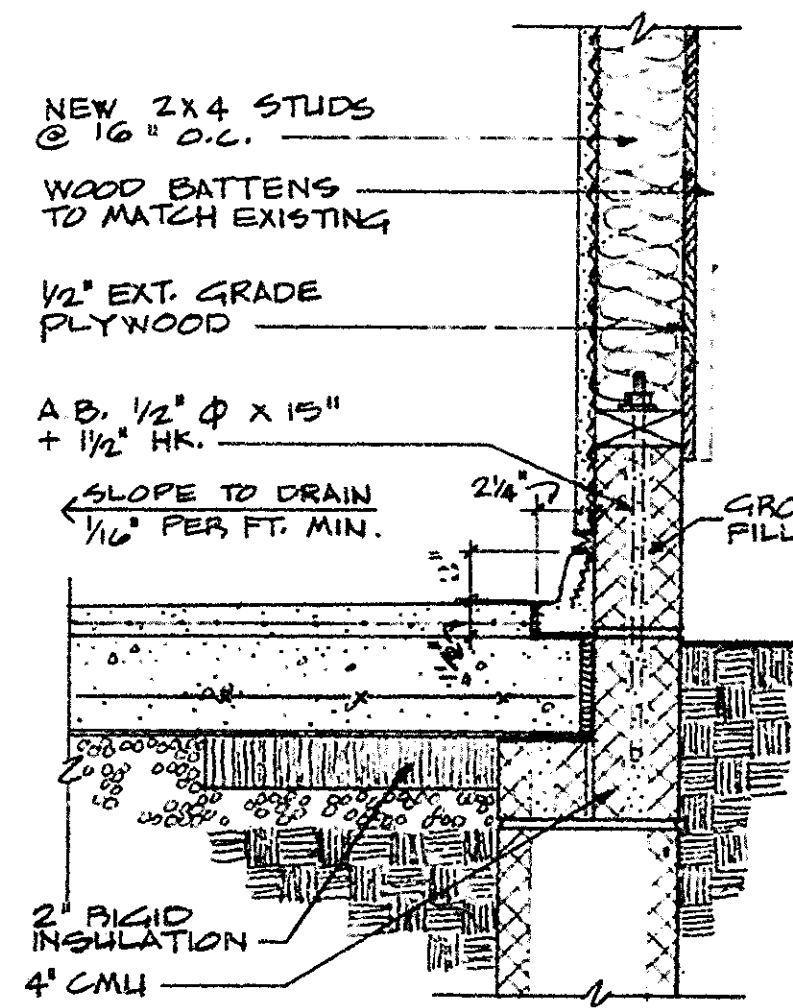

6 FOUNDATION
SCALE: 1/2" = 1'-0"



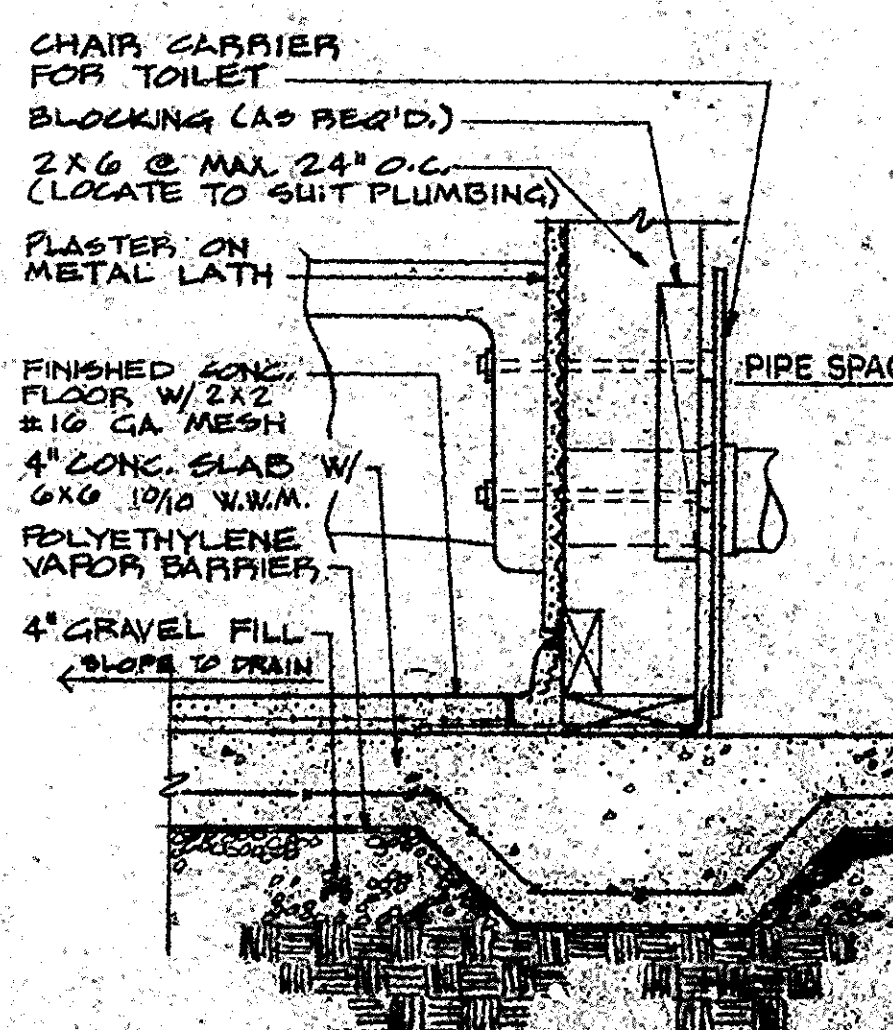


7 FOOTING DET.
SCALE: 1/2" = 1'-0"

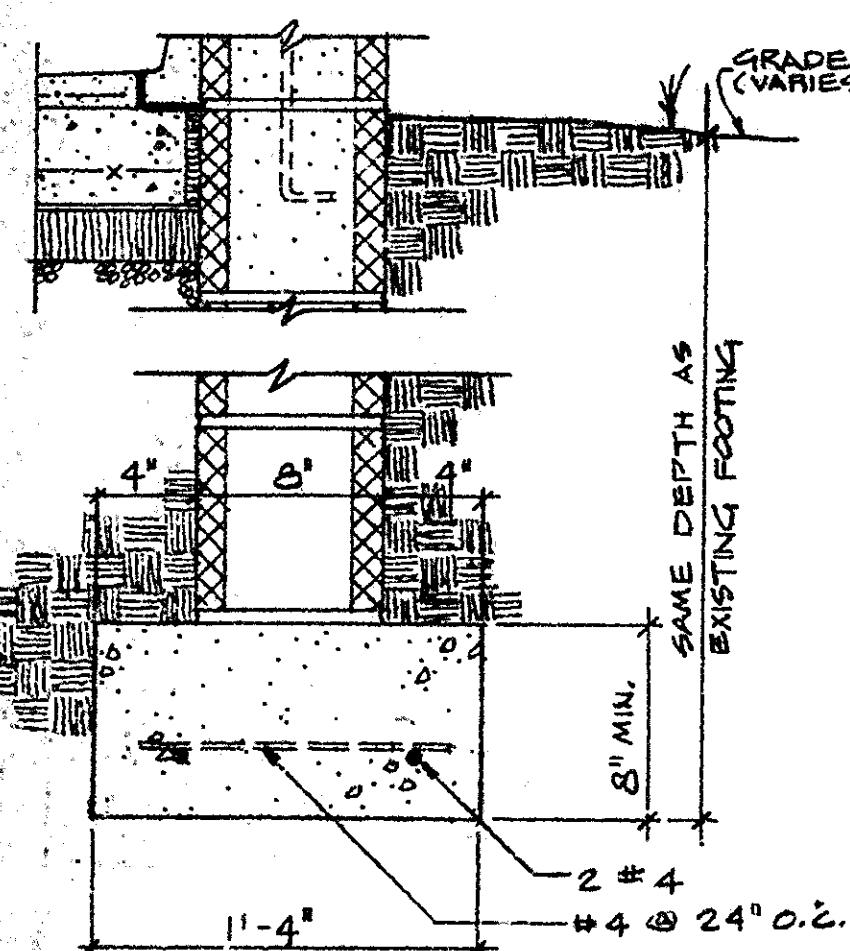


8 FOOTING DET.
SCALE: 1/2" = 1'-0"

PREPARED LUKENS	DRAWING NO. 326
DESIGNED SUMMERLIN	80006
DRAWN LUKENS	PCIP PKG.
CHECKED 11-30-79	SHEET 2
DATE	OF 3

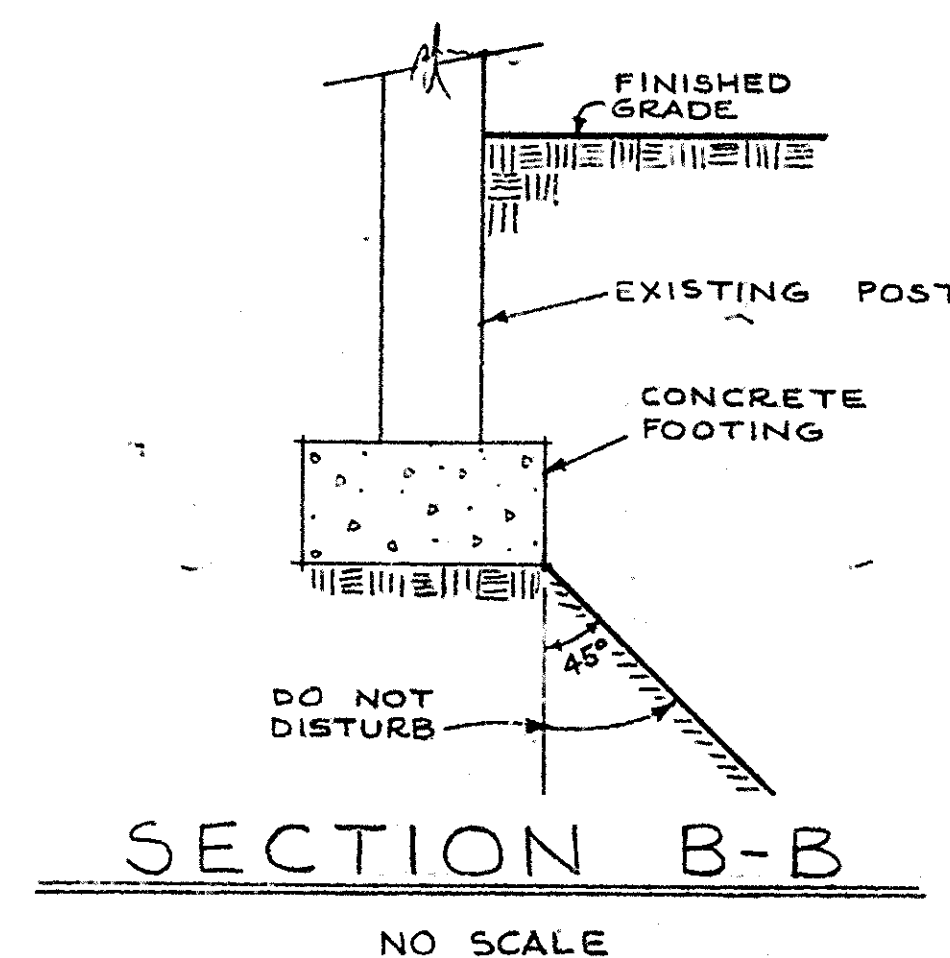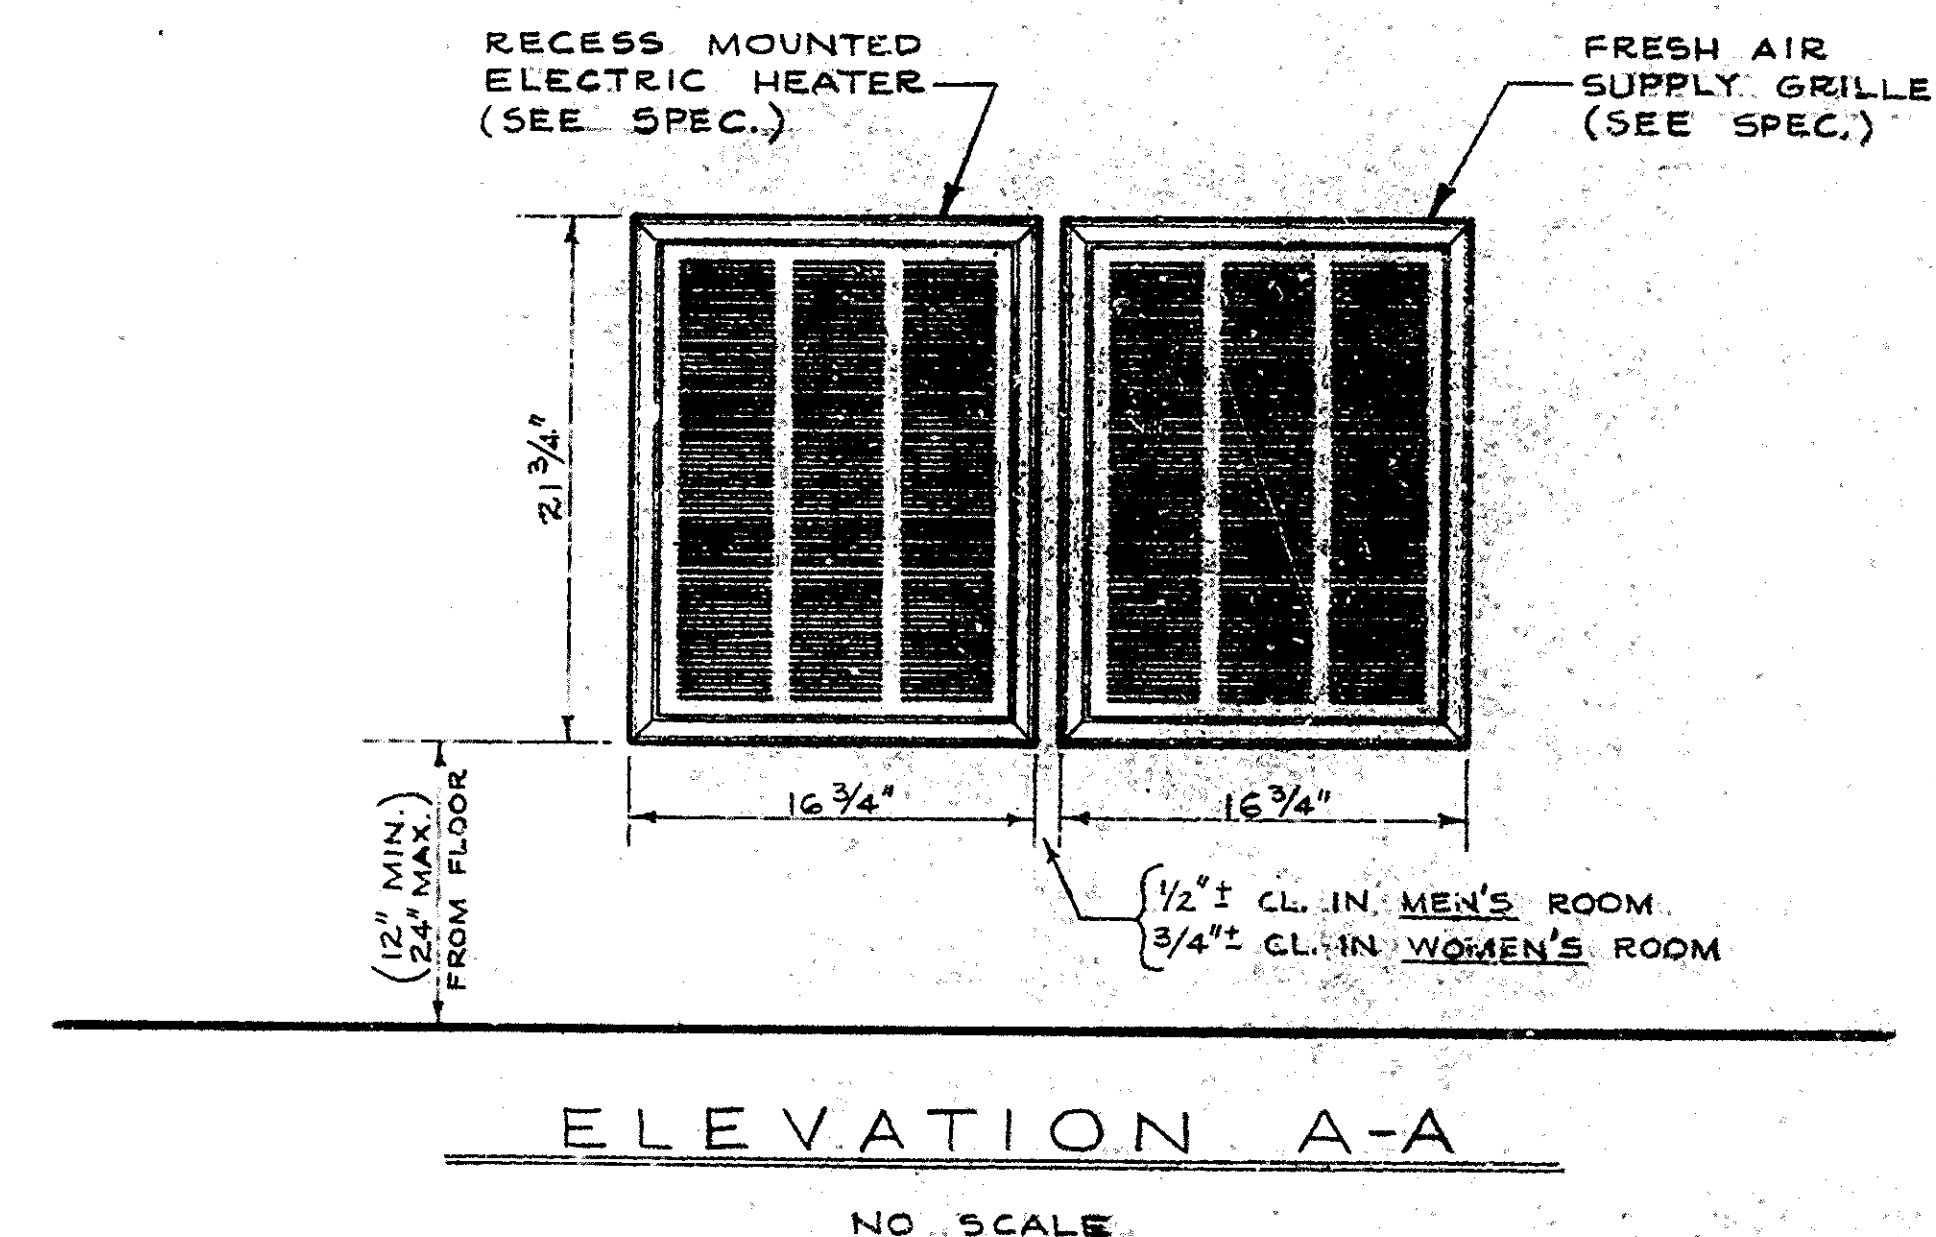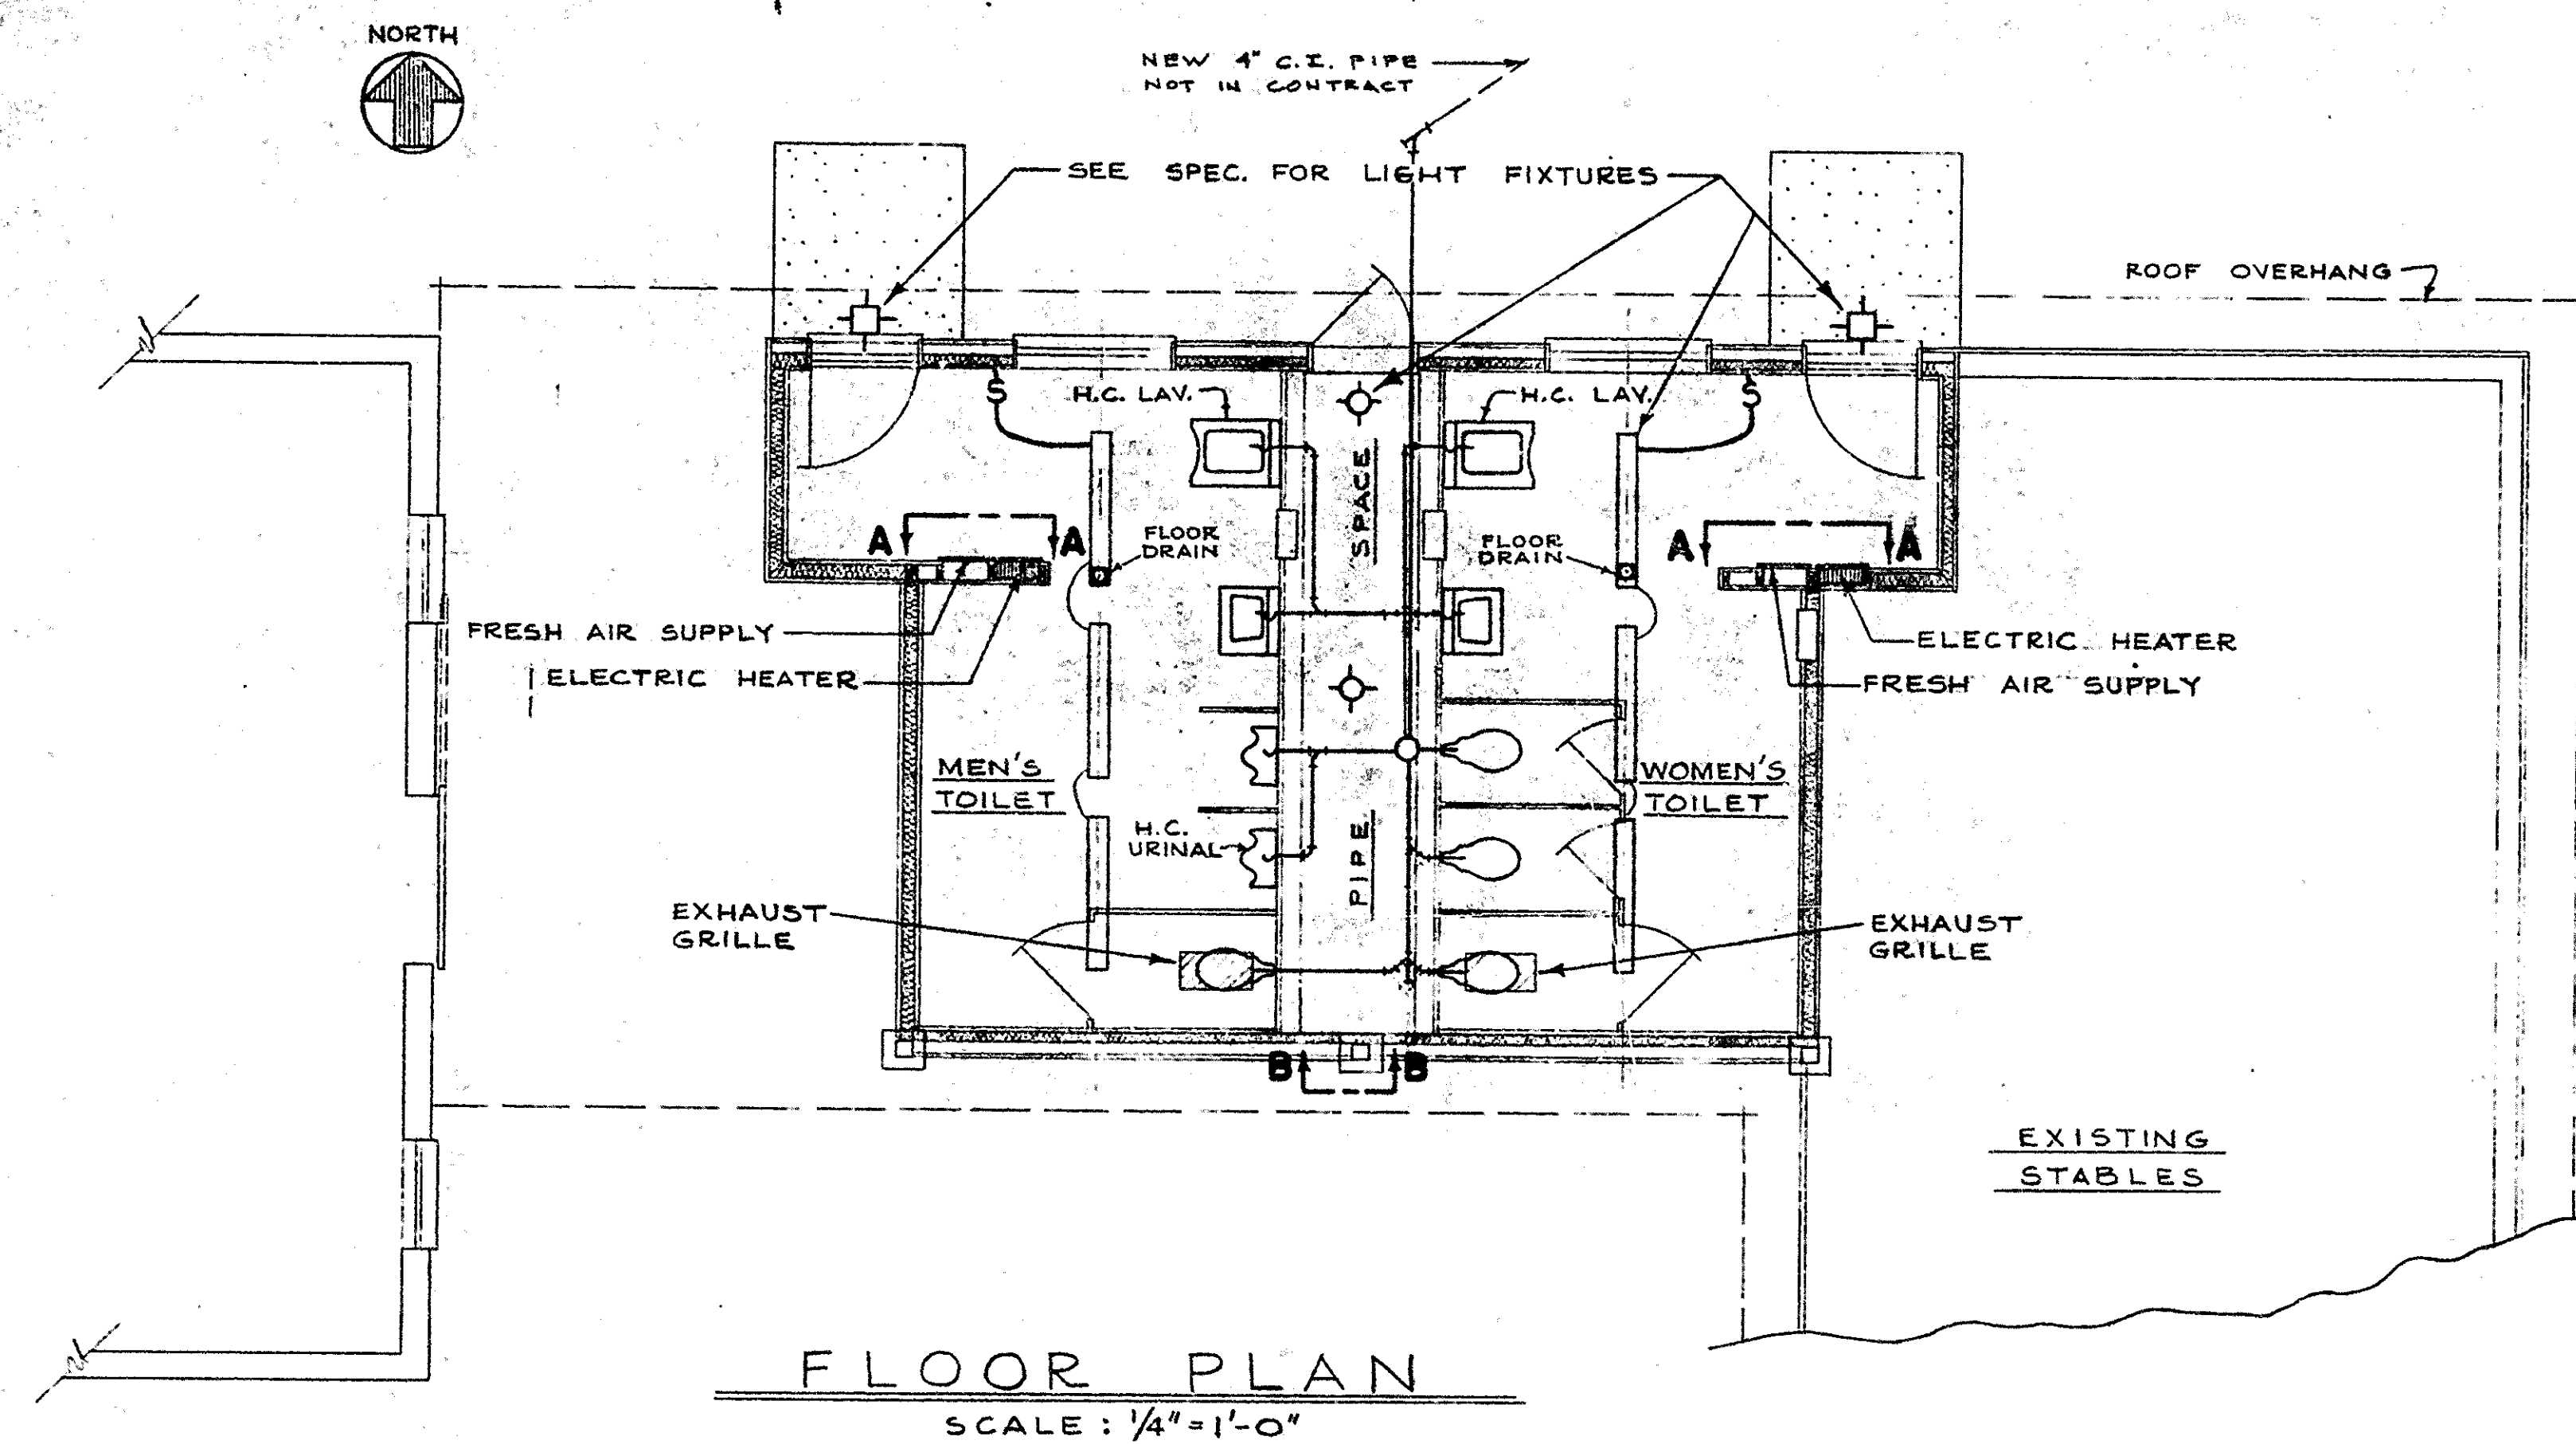

- CIRCUIT BREAKER PANEL -					
120-240 VOLT, 3 WIRE, SINGLE PHASE, 100 A. 2P. MAIN BREAKER					
CIRCUIT NO.	WIRE SIZE	BREAKER AMPS	NUMBER OF POLES	GROUND FAULT INTERRUPTER	CIRCUIT DESCRIPTION
1	14	15	1	NO	VENT. & LIGHTS - MEN
2	12	20	1	NO	WATER HEATER
3	10	30	2	YES	HEATER - MEN
4	10	30	2	YES	HEATER - WOMEN
5	14	15	1	NO	VENT. & LIGHTS - WOMEN & OUTSIDE
-	-	15	1	NO	SPARE

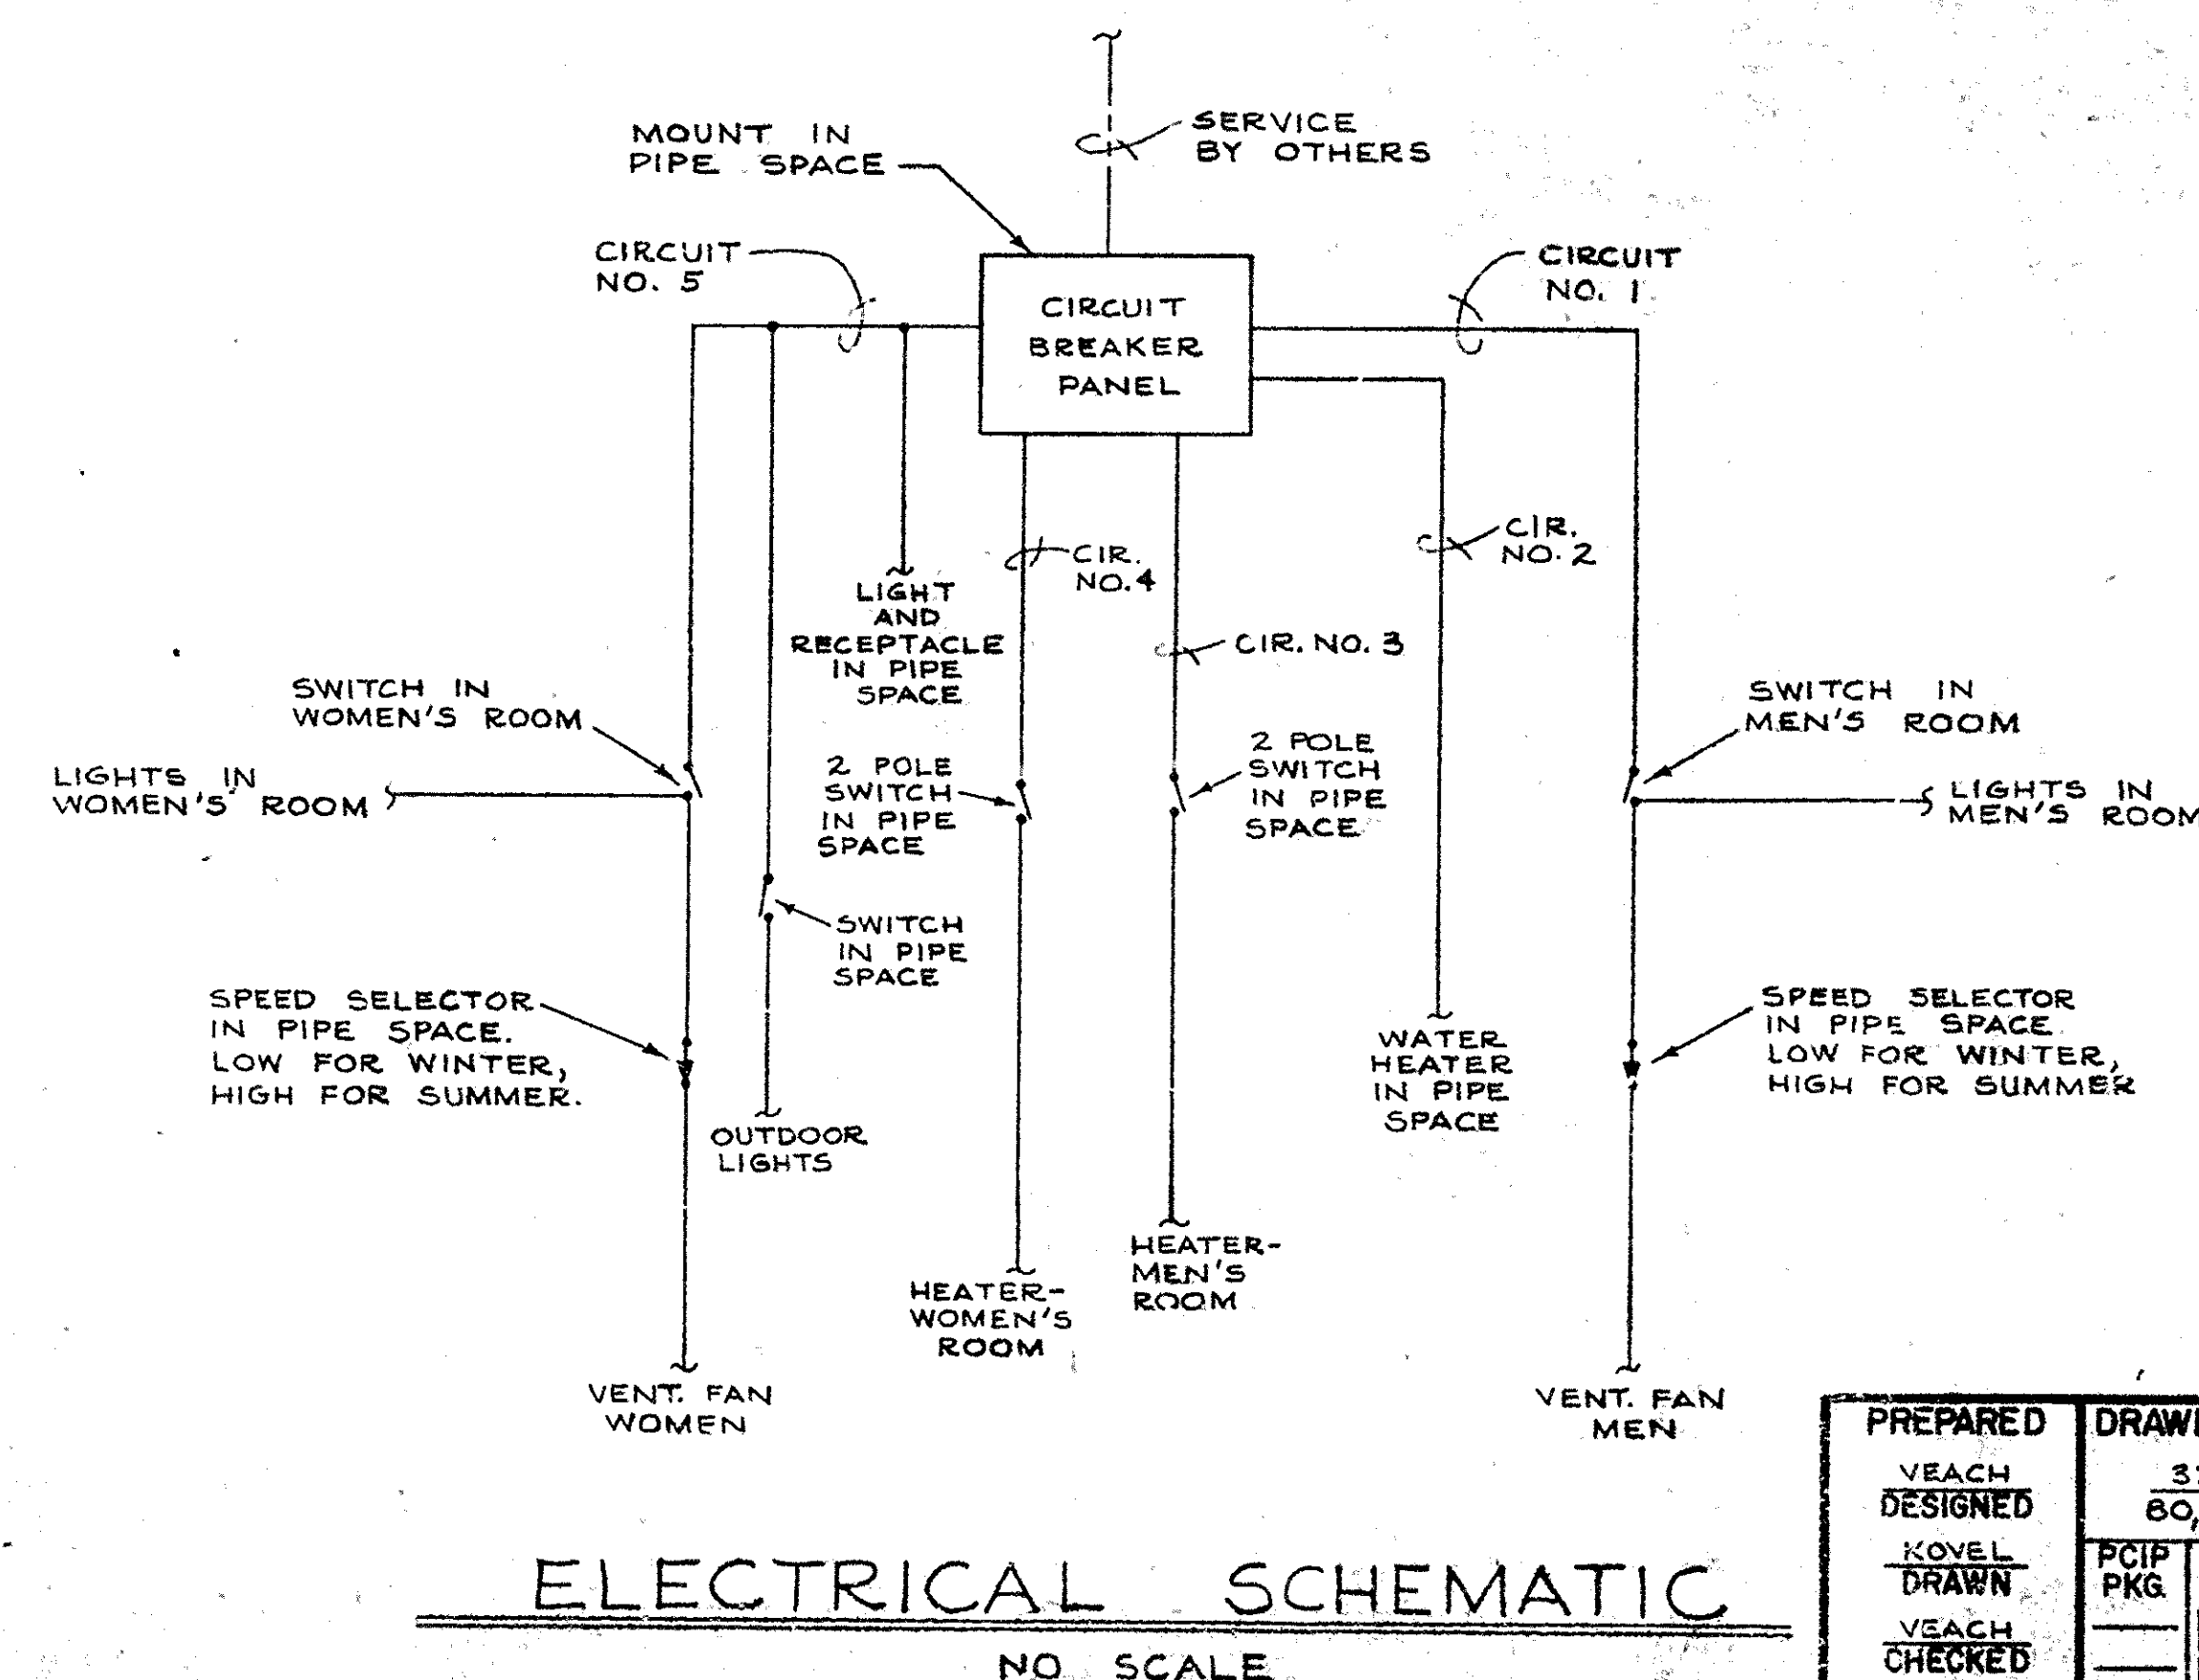

PREPARED	DRAWING NO.
VEACH DESIGNED	326
NOVEL DRAWN	80,006
VEACH CHECKED	PCIP PKG
DATE	SHEET
	3
	OF 3